


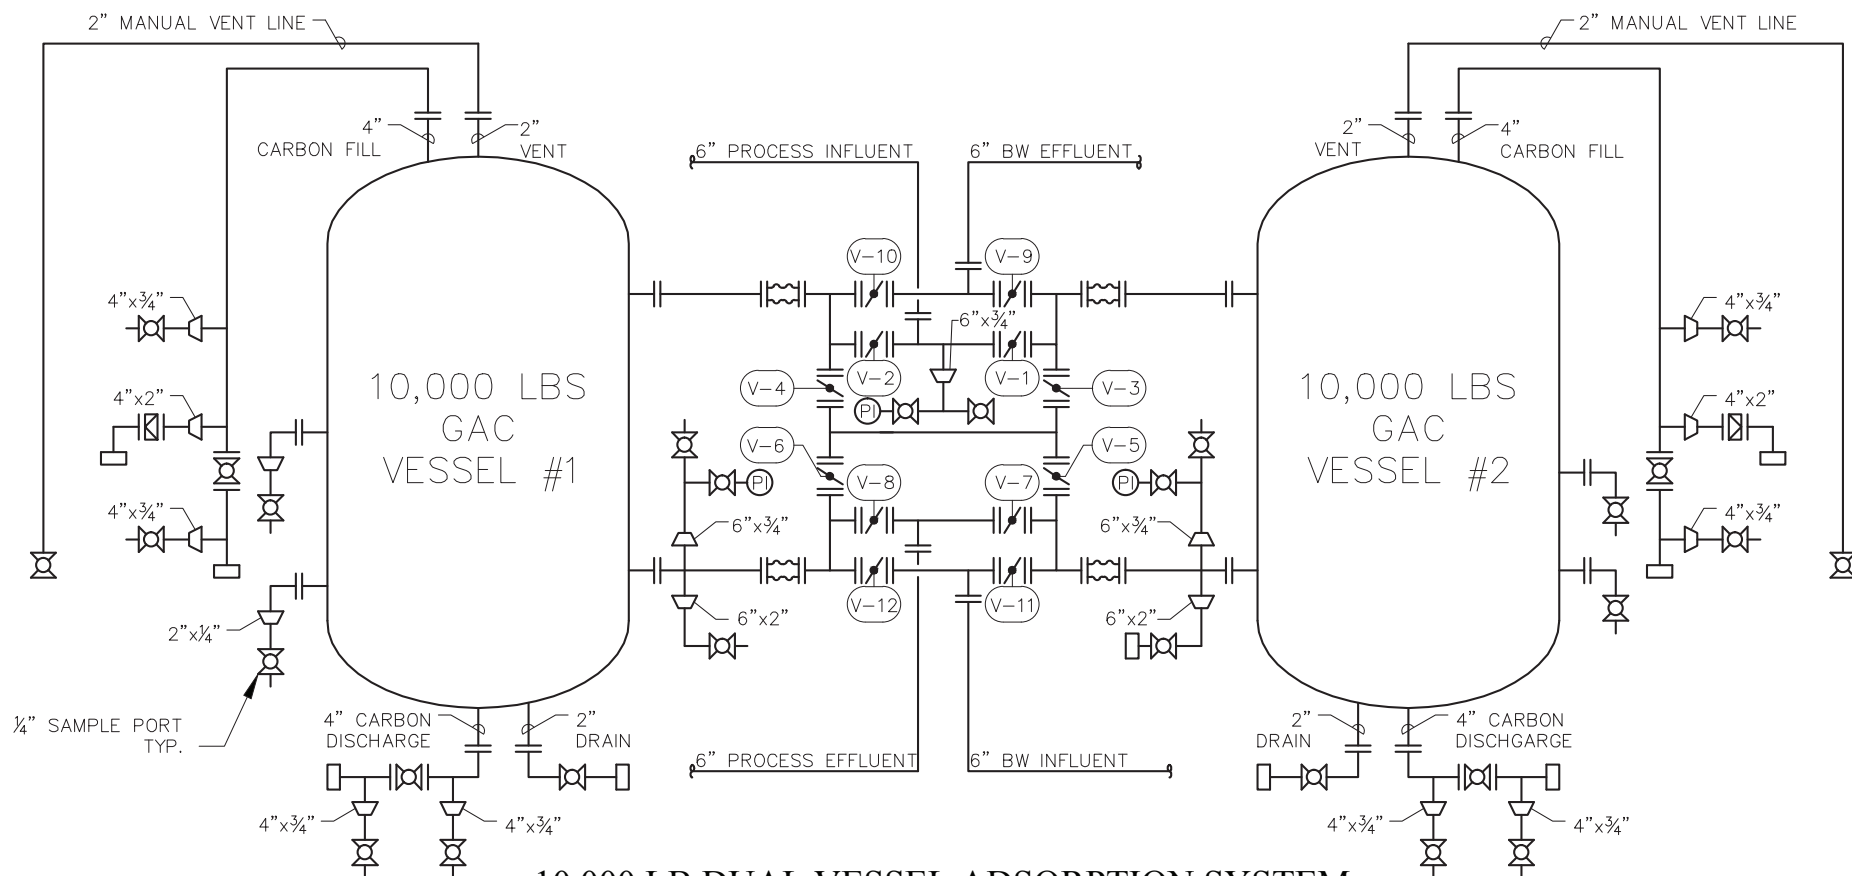

10,000 LB DUAL VESSEL ADSORPTION SYSTEM

LEGEND

	EXPANSION JOINT		REDUCER		RUPTURE DISK		BALL VALVE
	QUICK CONNECT CAM LOCK FITTING		MANUALLY OPERATED BUTTERFLY VALVE		PRESSURE GAUGE		

4			
3			
2			
1			
NO.	REVISION		BY DATE
PROJECT			
CP-10K-8		 newterra®	
PROJ. NO.		SALES	
P.O. NO.			
THIS DRAWING AND DESIGN ARE THE PROPERTY OF TIGG CORP. AND SHALL NOT BE REPRODUCED IN WHOLE OR IN PART, NOR EMPLOYED FOR ANY PURPOSE OTHER THAN SPECIFICALLY PERMITTED IN WRITING BY TIGG CORP. THIS DRAWING LOANED SUBJECT TO RETURN ON DEMAND.			
DRAWN BY	JAK	P&ID	
DESIGN BY	JB		
CHKD. BY	JB		
DATE	11/15/13		
SCALE	NTS	CP-10K-8-1002	
		REV. 0	